


PROPOSED	EXISTING	
SD	SD	STORMDRAIN LINE
SS	SS	SANITARY SEWER LINE
W	W	WATER LINE
OHE	OHE	OVERHEAD ELECTRIC LINE
UGE	UGE	UNDERGROUND ELECTRIC LINE
COM	COM	COMMUNICATIONS LINE
G	G	GAS LINE
COND	COND	CONDUIT PROPERTY LINE

	STORMDRAIN INLET
	STORMDRAIN COMBINATION BOX
	STORMDRAIN MANHOLE
	DOWNSPOUT (ROOF DRAIN W/CONNECTION)
	ROOFDRAIN (OUTLET TO LANDSCAPING)
	CLEANOUT
	SANITARY SEWER MANHOLE
	ELECTRICAL/TRANSFORMER BOX
	FIRE HYDRANT
	WATER METER
	WATER VALVE/POST INDICATOR VALVE
	FIRE DEPT. CONNECTION
	SITE LIGHT
	POWER POLE
	PAVEMENT PATCHING

- KEY TAGS:
- ① INSTALL SD CLEANOUT
 - ② INSTALL DOWNSPOUT CONNECTION
 - ③ INSTALL SS CLEANOUT

- GENERAL UTILITY NOTES:
- IT SHALL BE THE CONTRACTORS RESPONSIBILITY TO CONTACT BLUE STAKES FOR UTILITY MARKING. DIAL 811.
 - CONTRACTOR SHALL FOLLOW GUIDELINES & RECOMMENDATIONS OF PROJECT GEOTECHNICAL INVESTIGATION & ALL ADDENDUMS.
 - ALL UTILITY INSTALLATIONS SHALL BE DONE PER LOCAL JURISDICTION AND AGENCY REQUIREMENTS & SPECIFICATIONS.

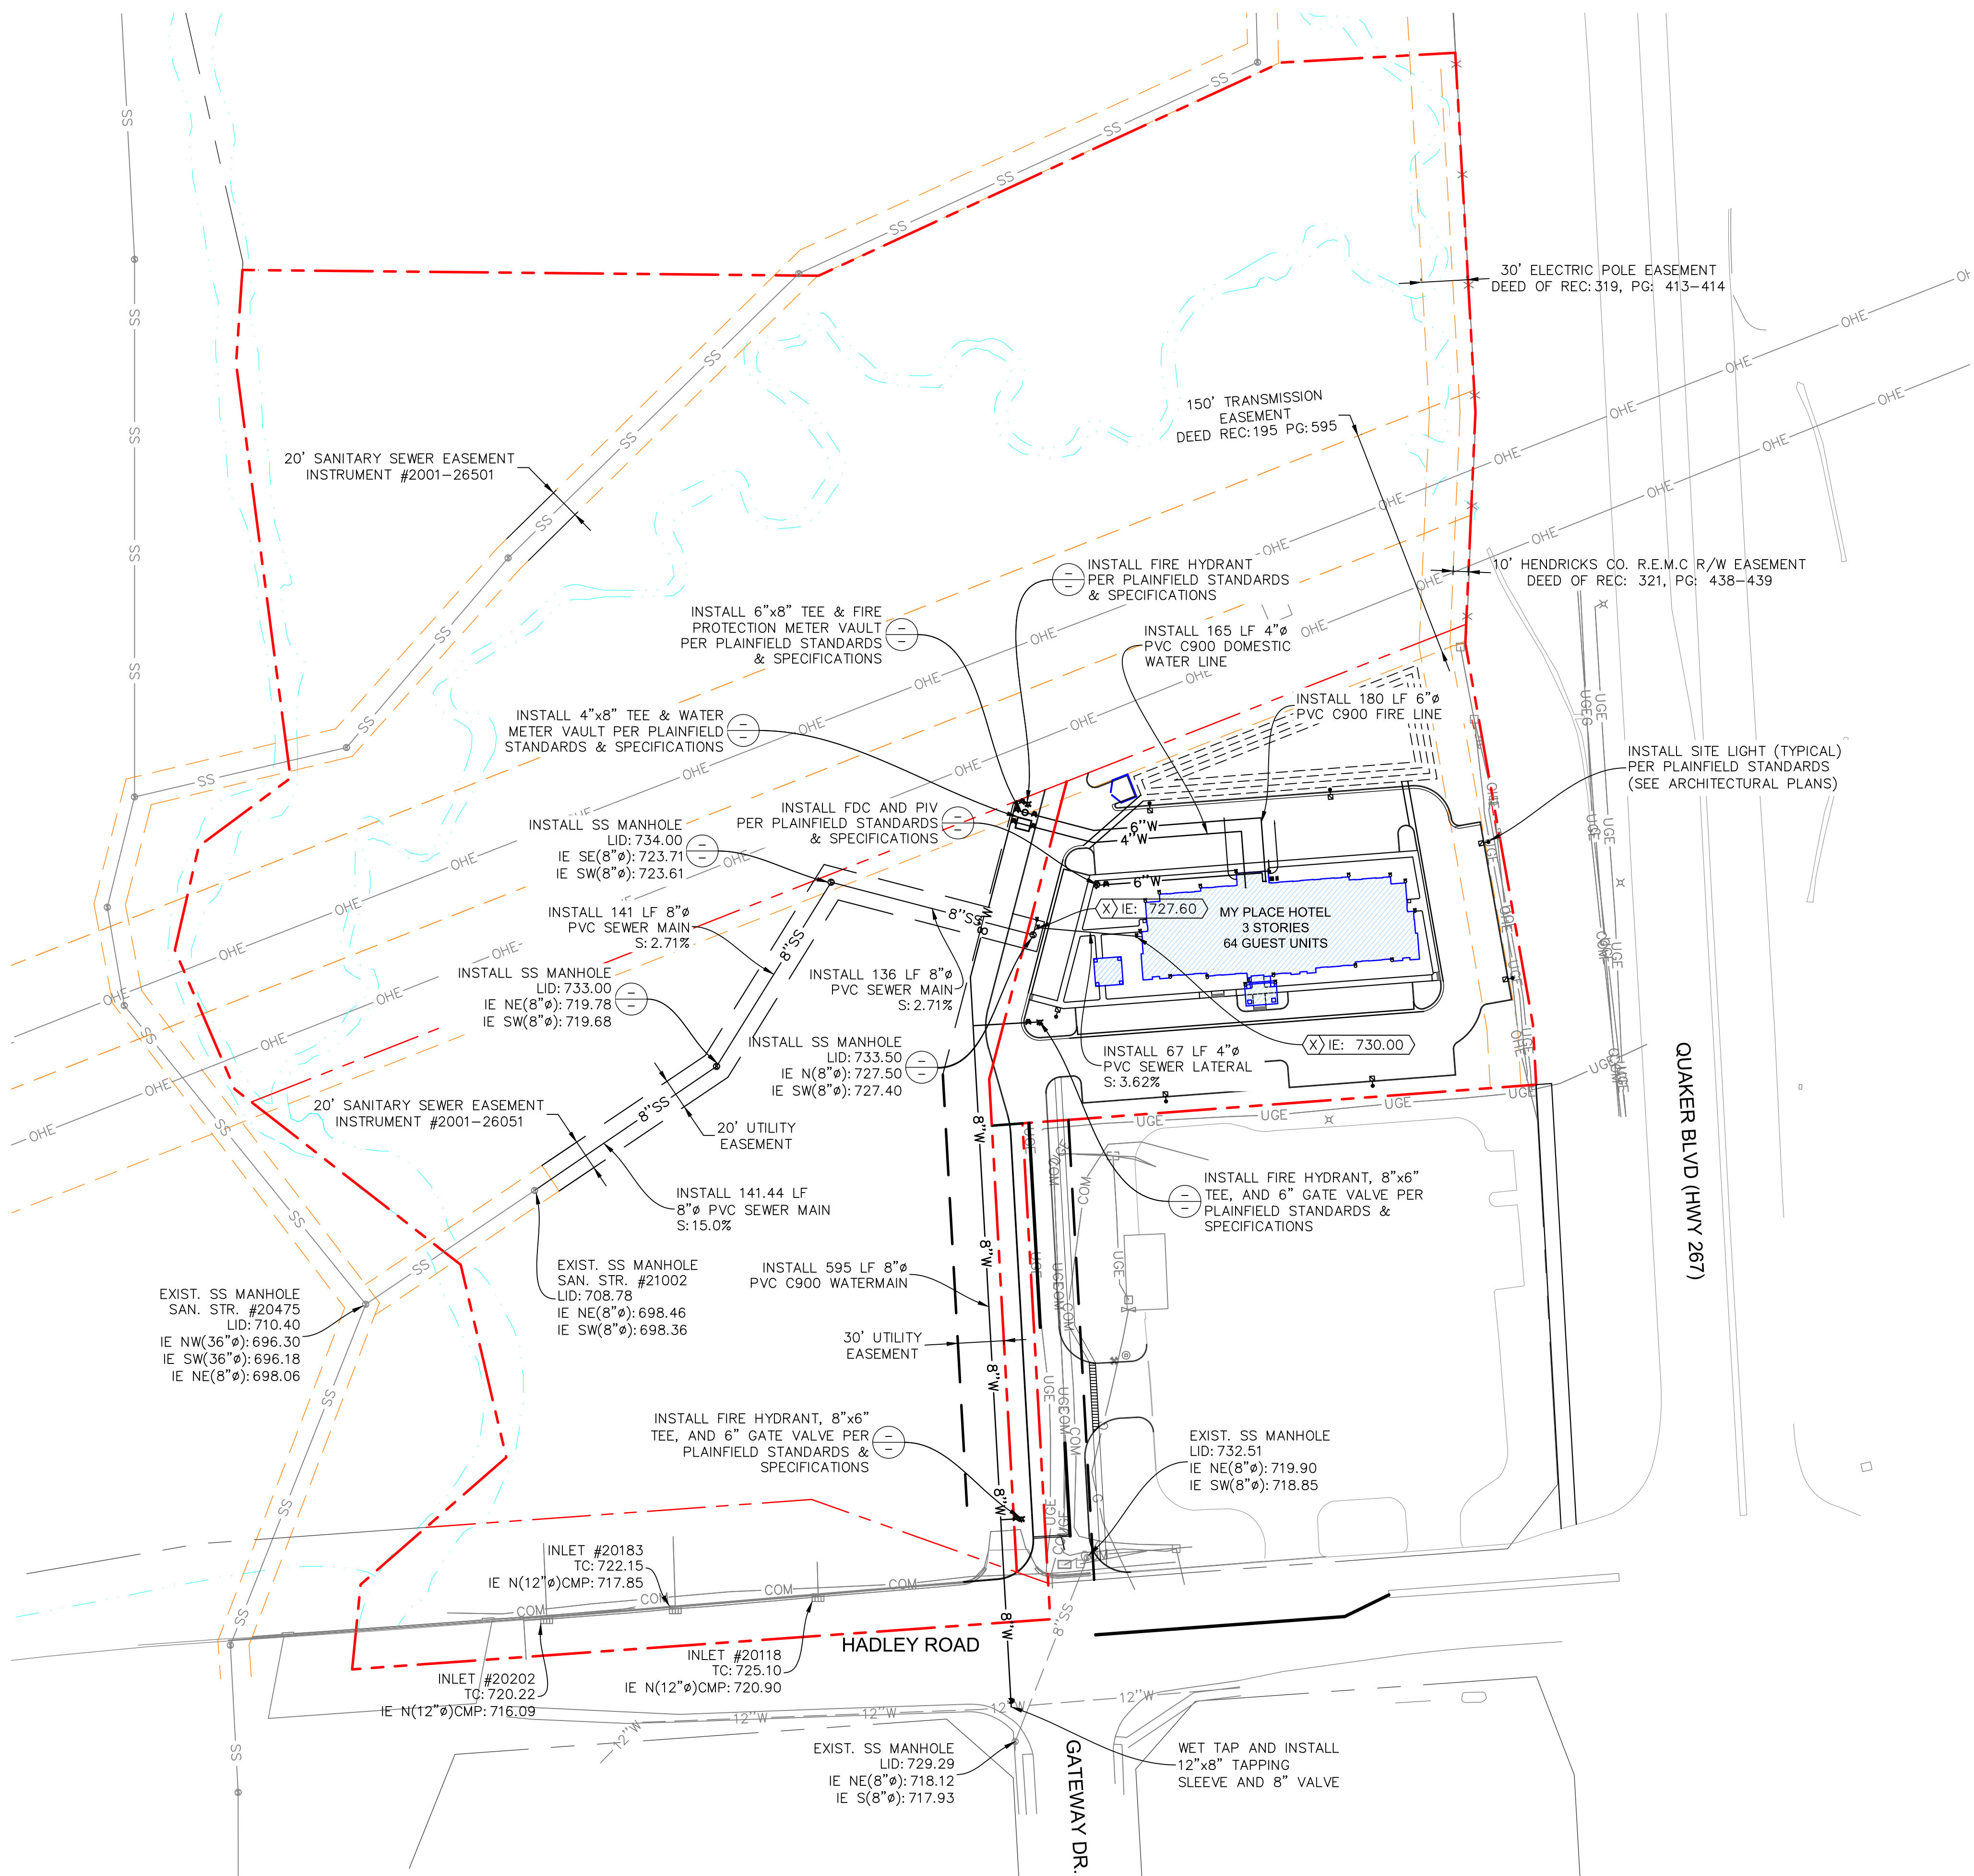


Preliminary
 02/23/2018 2:52:43 PM



Rev.	Date	Comment

DRAWN BY: BMA
 DESIGN BY: BMA
 ORIG. ISSUE DATE:

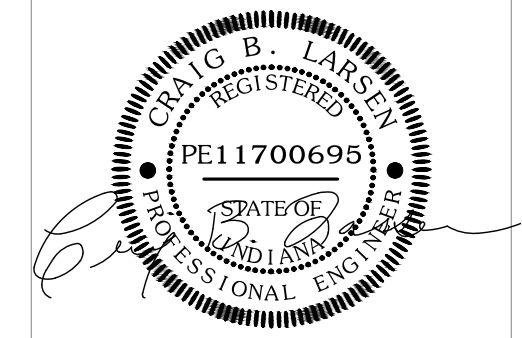

2/23/2018 2:42:24 PM

UTILITY PLAN
C200

