
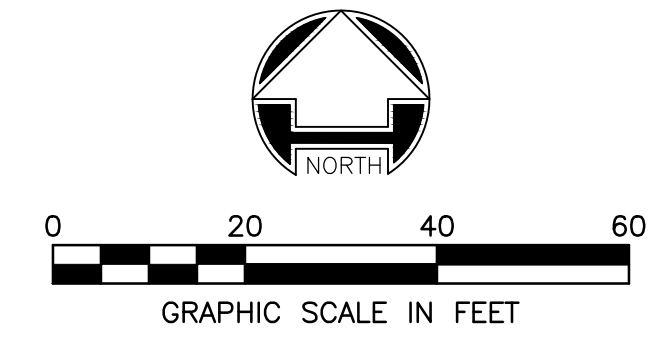


Layout Tab Name: C700, Images: , Xrefs: 78560TELK.dwg, 78560-p.dwg, 78560-x.dwg
 Last Saved By: Smith, 7/18/2018 11:15:49 AM
 G:\DE\clients\Enright_Architects\78560 - Belle Tire - Plainfield\4.0 Disciplines\Civil\Cadd\Cad\78560LTC.dwg Plotted: July 19, 2018, 4:01:58 PM

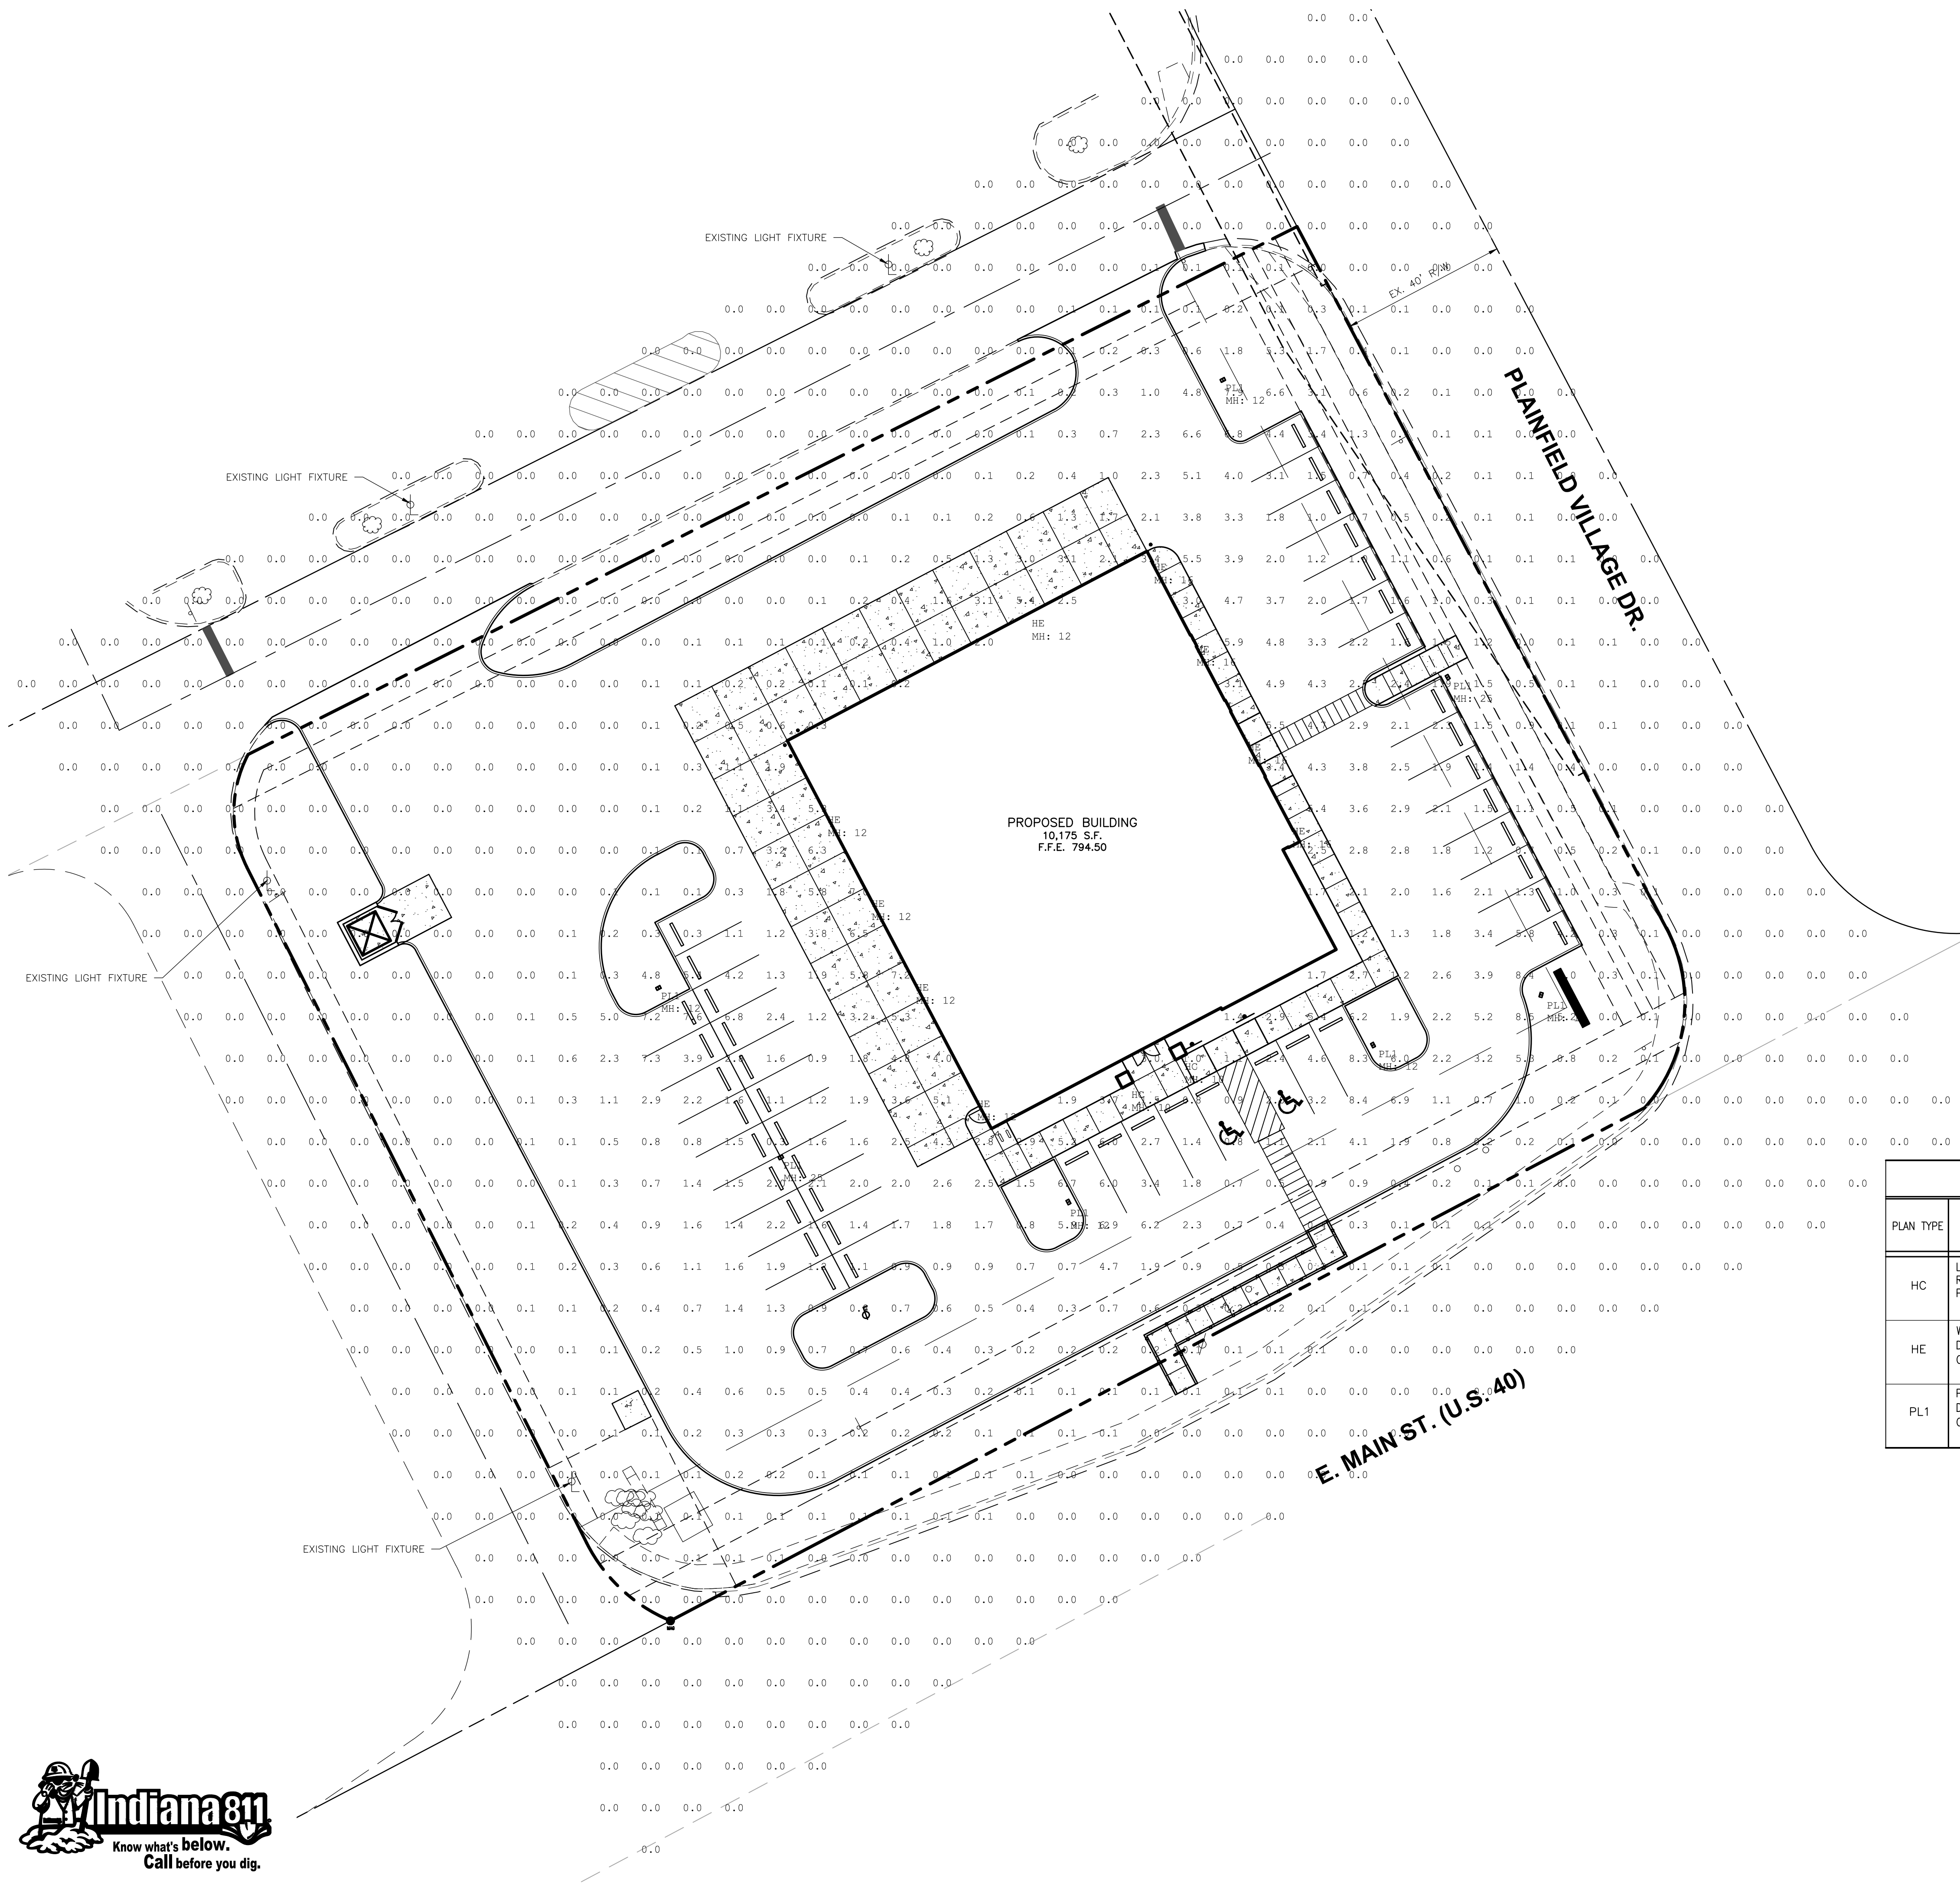

LIGHTING FIXTURE SCHEDULE						
PLAN TYPE	MANUFACTURER	MOUNTING	LAMPS		VOLTAGE	DESCRIPTION/REMARKS
			NO.	WATTS TYPE/LU		
HC	LBL LIGHTING DECORATIVE WALL SCNCE RATED FOR WET CONDITIONS. PW530 SS 25L1HE W.	WALL MOUNT	2	50 T8 BI-PIN	120/277	DECORATIVE WALL SCNCE
HE	WALL MOUNTED FLOOD, TYPE 3 DISTRIBUTION, 42W, 120/277V, BRONZE CREE #XSPWA-3MC U Z	WALL MOUNT	9	42 LED	120/277	DECORATIVE WALL SCNCE
PL1	POLE MOUNTED FLOOD, TYPE IV MEDIUM DISTRIBUTION, 86W, 120/277V, BRONZE CREE #0SQANM-4ME B 57K UL BZ	POLE MOUNT	7	86 LED/1,213	120/277	LED ARCHITECTURAL AREA LUMINAIRE WITH CUTOFF TYPE IV SHORT OPTICS. POLE AND FIXTURE FINISHES TO BE BRONZE.

REVISION	No.	DATE

PROJECT No: 78560
 DATE 07/20/18
 DES. ARS
 DR. PJD
 CKD. JRN

7635 Interactive Way
 Suite 100
 Indianapolis, IN 46278
 317.299.7500
 FAX: 317.291.5805

BELLE TIRE STORE #150

2708 EAST MAIN STREET
 PLAINFIELD, INDIANA

LIGHTING PLAN

SHEET NO.
C700