


U.S. HIGHWAY 40 (E. MAIN STREET)

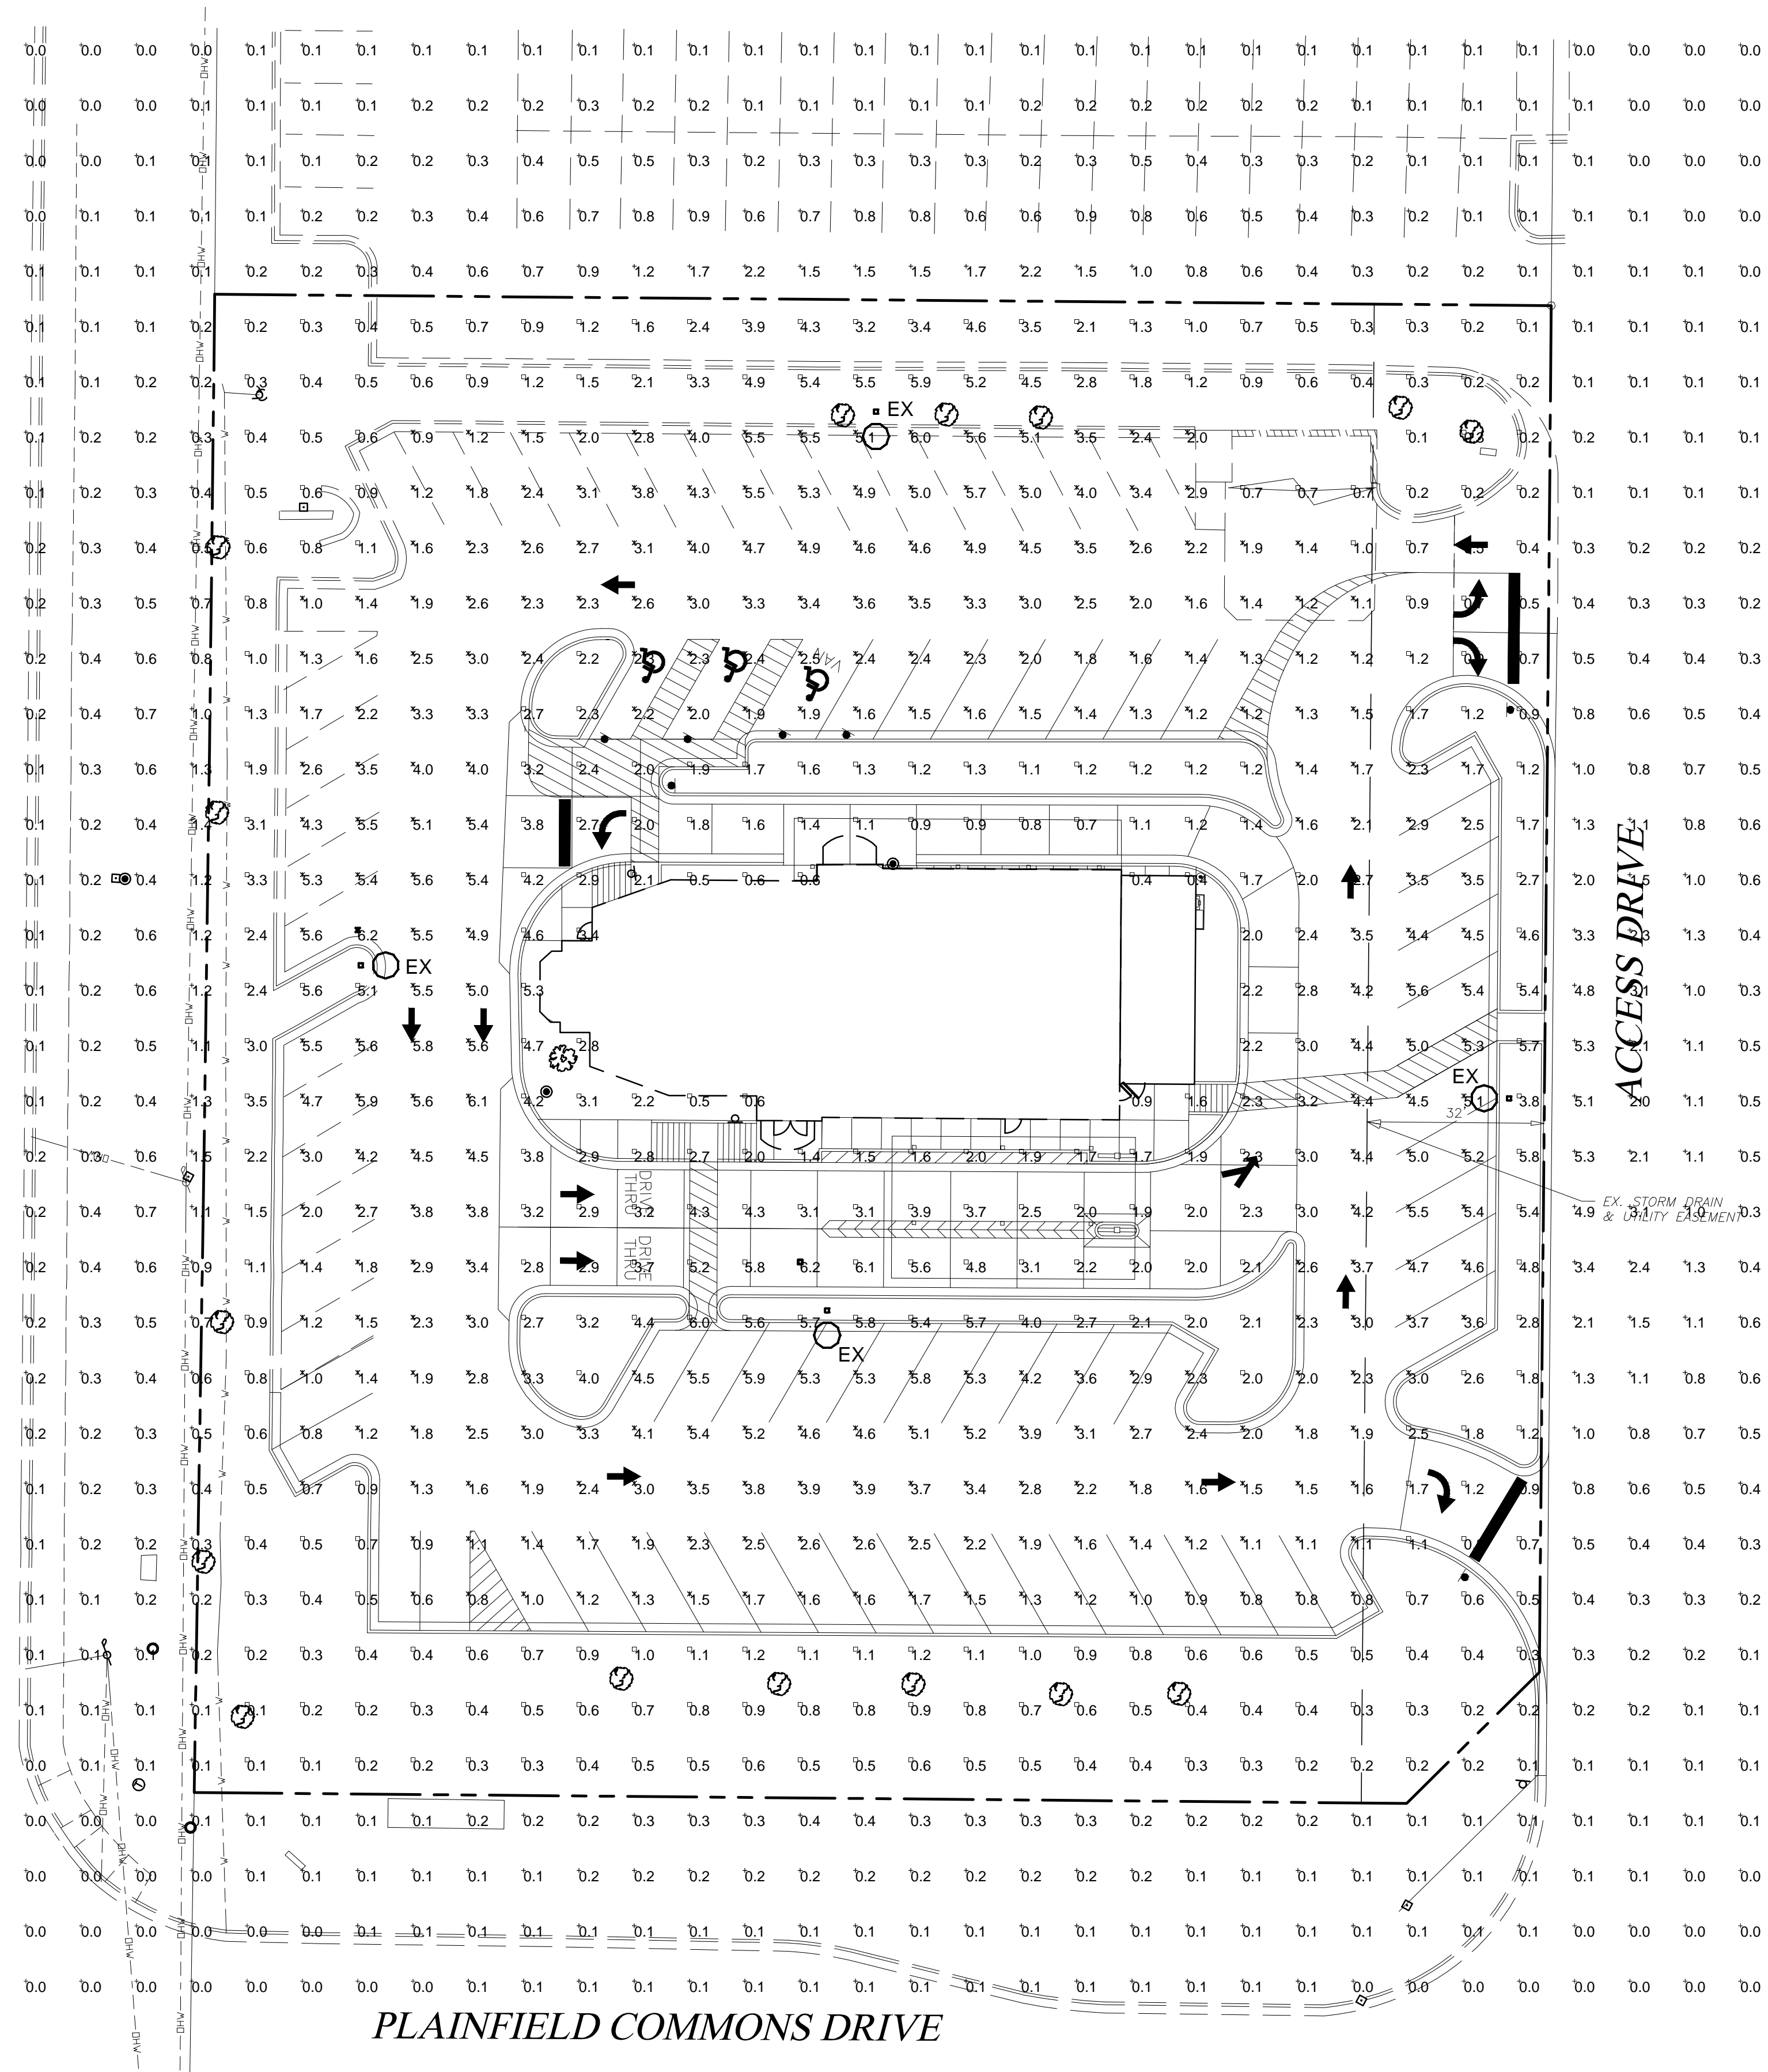

PLAINFIELD COMMONS DRIVE




LUMINAIRE SCHEDULE								
Symbol	Label	Qty	Catalog Number	Description	Lamp	Lumens	LLF	Watts
○	EX	4	EXISTING SITE LTG MCGRAW-EDISON GRL-XX-1000-MH- XX-3V-SG-XX-HS	LARGE ARCHITECTURAL AREA FIXTURE- VERTICAL LAMP-TYPE III DISTRIBUTION W/ HSS	1000 W MH	110000	0.65	1000

STATISTICS						
Description	Symbol	Avg	Max	Min	Max/Min	Avg/Min
Lot Light Summary	□	2.4 fc	6.2 fc	0.1 fc	62.0:1	24.0:1
Parking Lot Lighting	✕	3.0 fc	6.2 fc	0.6 fc	10.3:1	5.0:1
Spill Light Summary	+	1.3 fc	6.2 fc	0.0 fc	N/A	N/A

LUMINAIRE MOUNTING HEIGHT		
No.	Label	MH
1	EX	25.0
2	EX	25.0
3	EX	25.0
4	EX	25.0

NOTE: EXISTING SITE LIGHTING IS MODELED AFTER THE ORIGINAL PERMIT DRAWINGS FOR THIS SITE. THE PHOTOMETRIC FILES FOR THE ORIGINAL SITE FIXTURES ARE NO LONGER AVAILABLE. THE MCGRAW-EDISON FIXTURE WAS SUBSTITUTED IN ORDER TO ESTIMATE THE LIGHTING LEVELS.

PHOTOMETRIC PLAN
SCALE: 1"=20'-0"

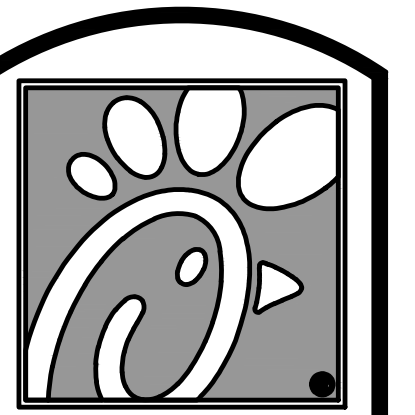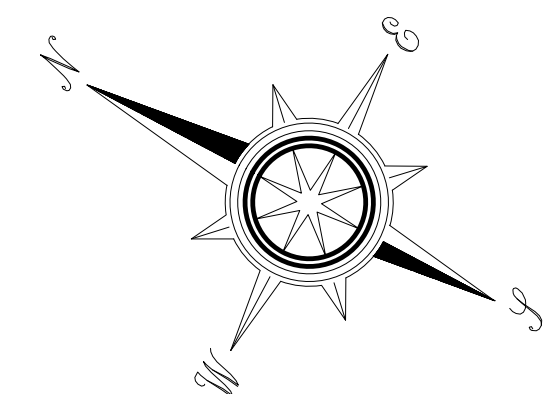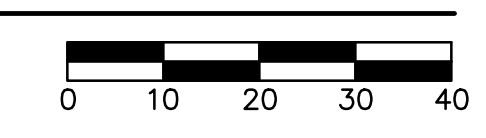

Chick-fil-A

5200 Buffington Rd.
Atlanta Georgia,
30349-2998

Revisions:
Mark Date By

△ _____

Mark Date By

△ _____

Mark Date By

△ _____



Kurzynski & Associates
CONSULTING ENGINEERS
2900 Lebanon Pike, Ste. 201
Nashville, Tennessee 37214
Telephone: (615) 255-5203
Fax: (615) 255-5207
Email: mail@kurzynskie.com

STORE #01405
PLAINFIELD FSU

2687 E. MAIN STREET,
PLAINFIELD, IN
46168

SHEET TITLE
Photometric
Plan

VERSION: 97-136
ISSUE DATE: 03.2018

Job No. : 18037
Store : 01405
Date : 04.03.18
Drawn By : ES
Checked By: MK

Sheet
E1.5